


PLAN NOTES

1. PROVIDE STRAPPING AS REQUIRED TO SUPPORT WALL PANELS.
2. ALL FABRIC WRAPPED PANELS TO BE RAILROADED. OPERABLE PARTITION PANEL FABRIC TO RUN AT REGULAR WIDTH.
3. VERTICALLY ALIGN THE TOP OF NEW AND EXISTING OUTLETS, AND ALIGN TOP OF SWITCHES ON THE WALLS.
4. ENSURE ALL SURFACES DESIGNATED TO RECEIVE FINISHES ARE CLEAN, TRUE & FREE OF IRREGULARITIES. DO NOT PROCEED WITH WORK UNTIL UNSATISFACTORY CONDITIONS HAVE BEEN CORRECTED.
5. FOR ALL FLOOR FINISHES, INSTALLER TO PROVIDE SEAMING DIAGRAMS TO ARCHITECT FOR APPROVAL PRIOR TO INSTALLATION. LOCATE TRANSITIONS UNDER DOORS.
6. WHERE THERE IS NOT AN EXISTING THRESHOLD OR FLOORING TRANSITION STRIP AT DOORS WITH NEW CARPET, PROVIDE A RUBBER TRANSITION OR REDUCER.
7. CORNER PROTECTION IS NOTED AS FOLLOWS: CG = CG-01; DM = DECO MTL-02

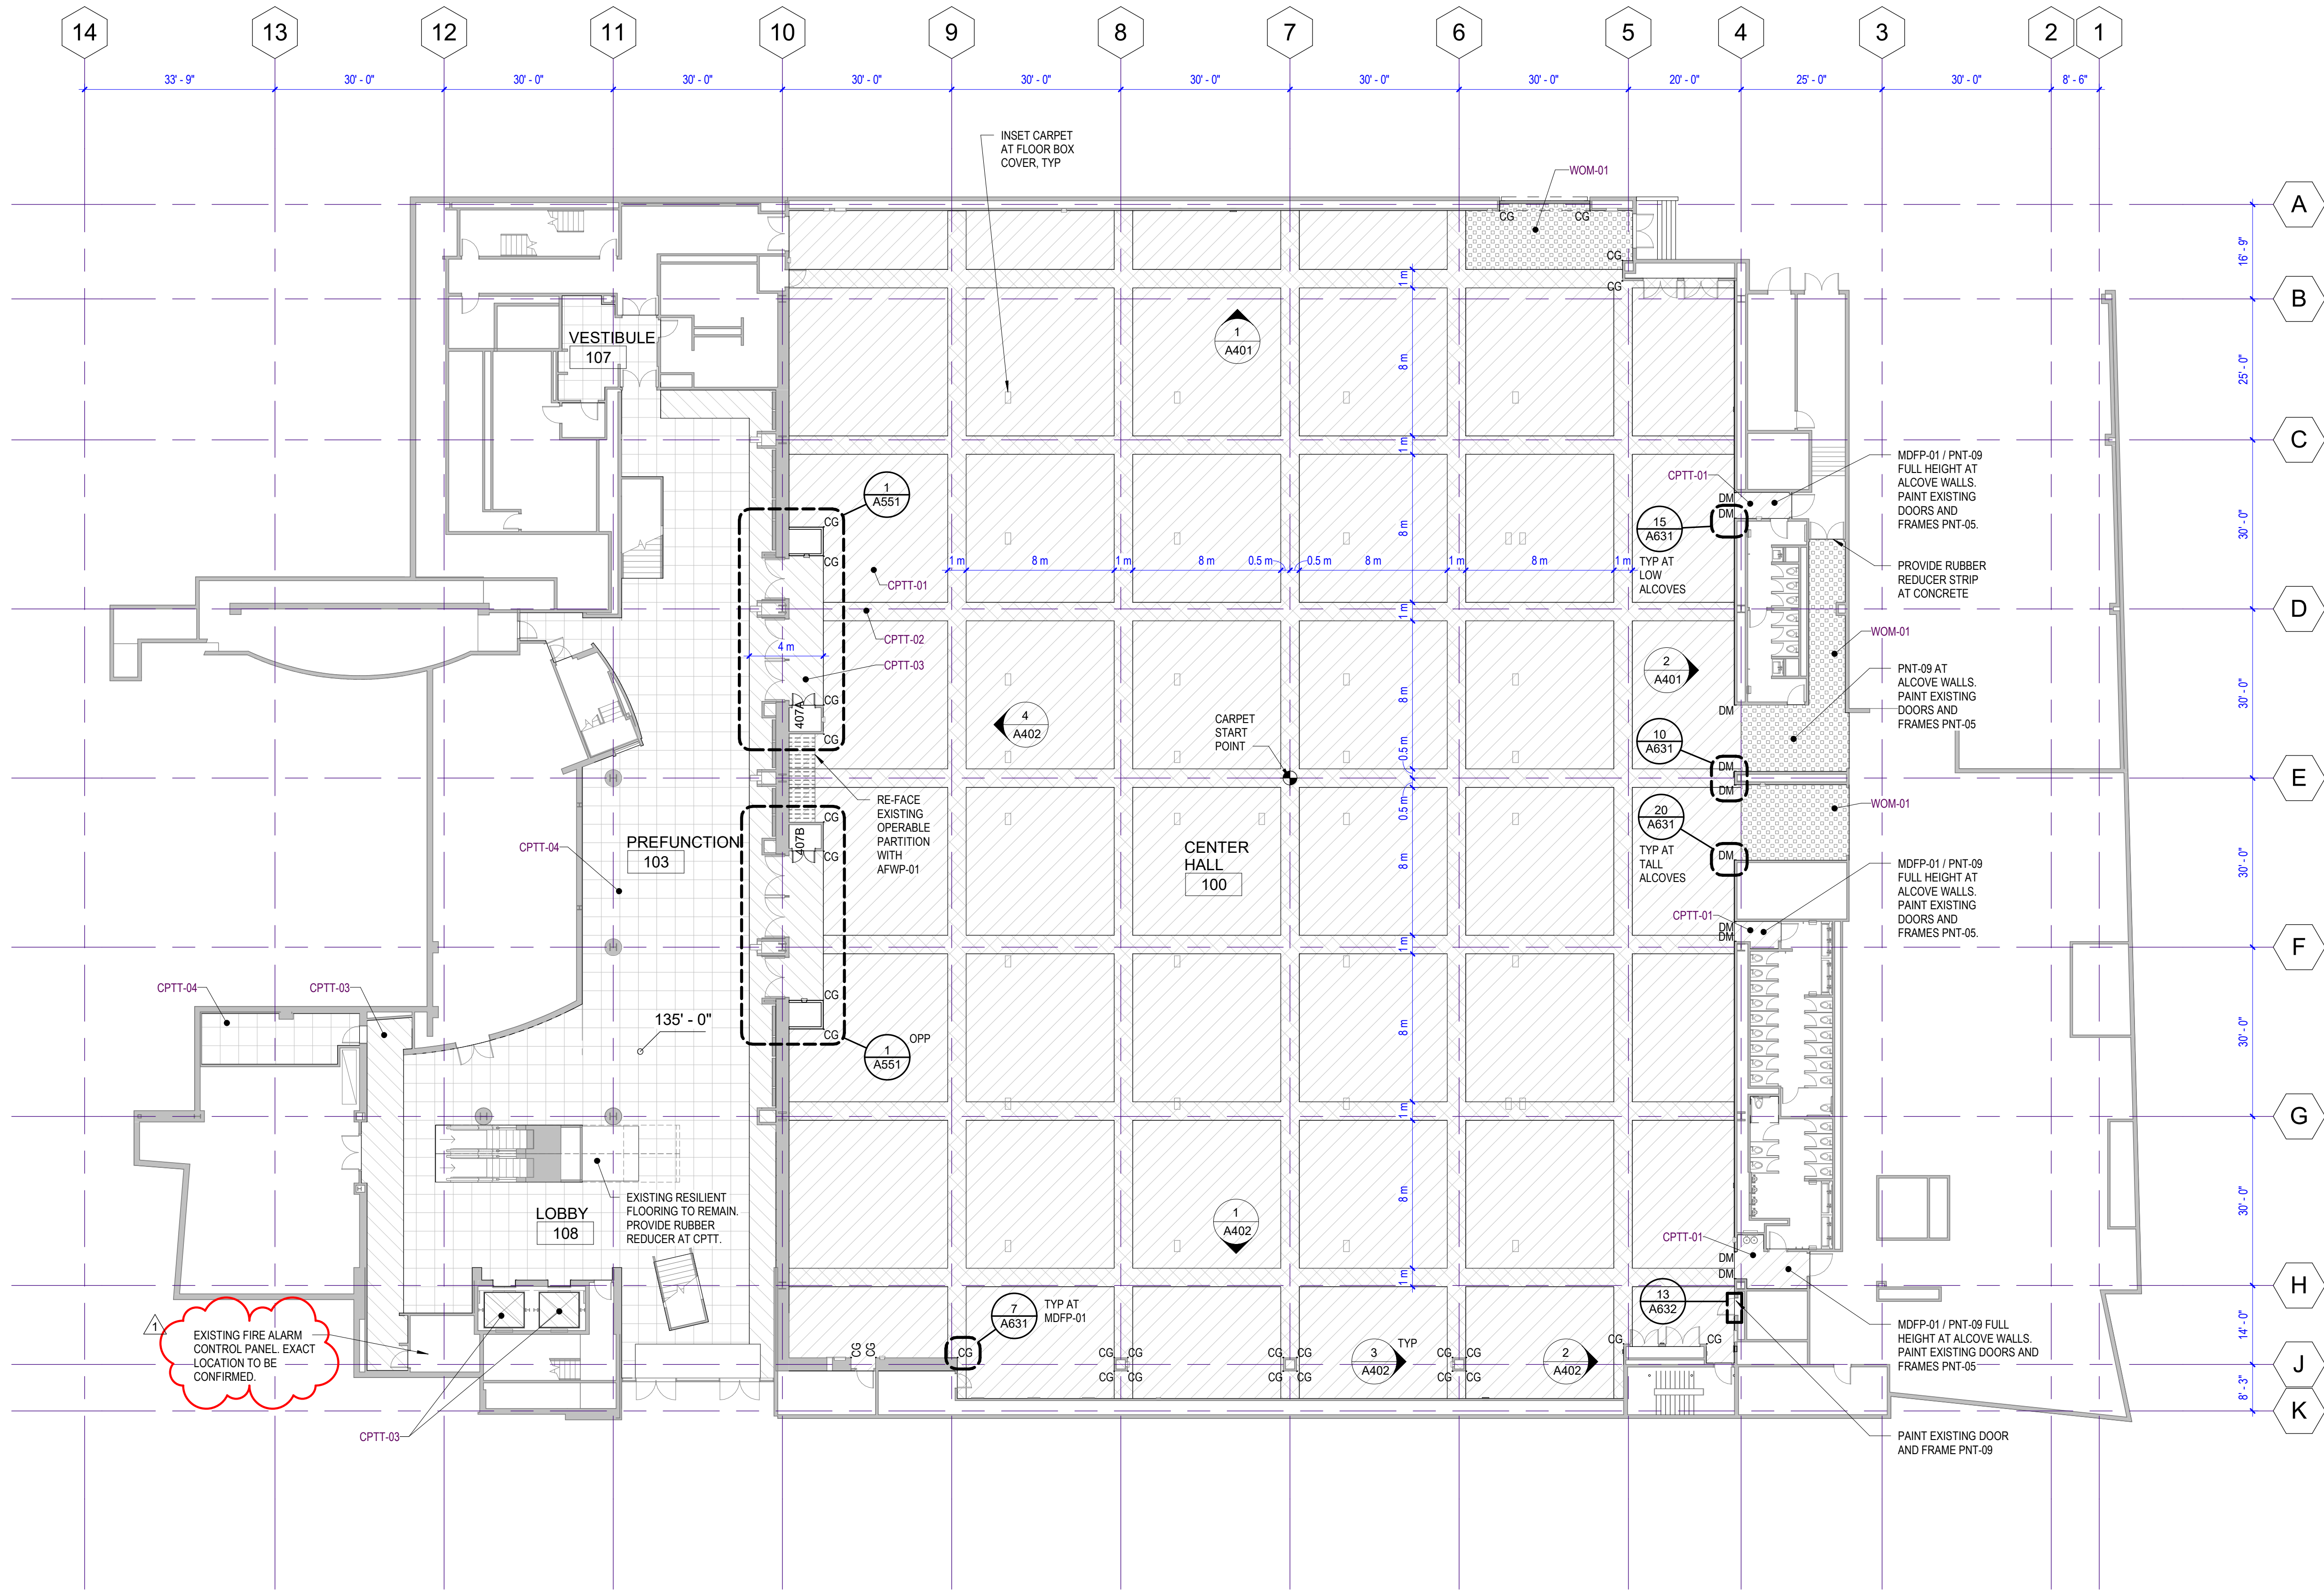

1 OVERALL PLAN - LEVEL 1  
A101 1/16" = 1'-0"

Meydenbauer  
Center:  
Center Hall  
Remodel

11100 NE 6th Street, Bellevue, Washington 98004

Submittal

CONSTRUCTION  
DOCUMENTS

Revisions

| No. | Date       | By | Description |
|-----|------------|----|-------------|
| 1   | 01/26/2026 |    | ADDENDUM #1 |

Drawn JS  
Checked JS  
LMN Proj No 24101-01  
Date 1/5/2026

Sheet Title

FLOOR PLAN -  
LEVEL 1


Sheet Number

A101

1  
E101

# ELECTRICAL POWER PLAN - LEVEL 1

1/16" = 1'-0"

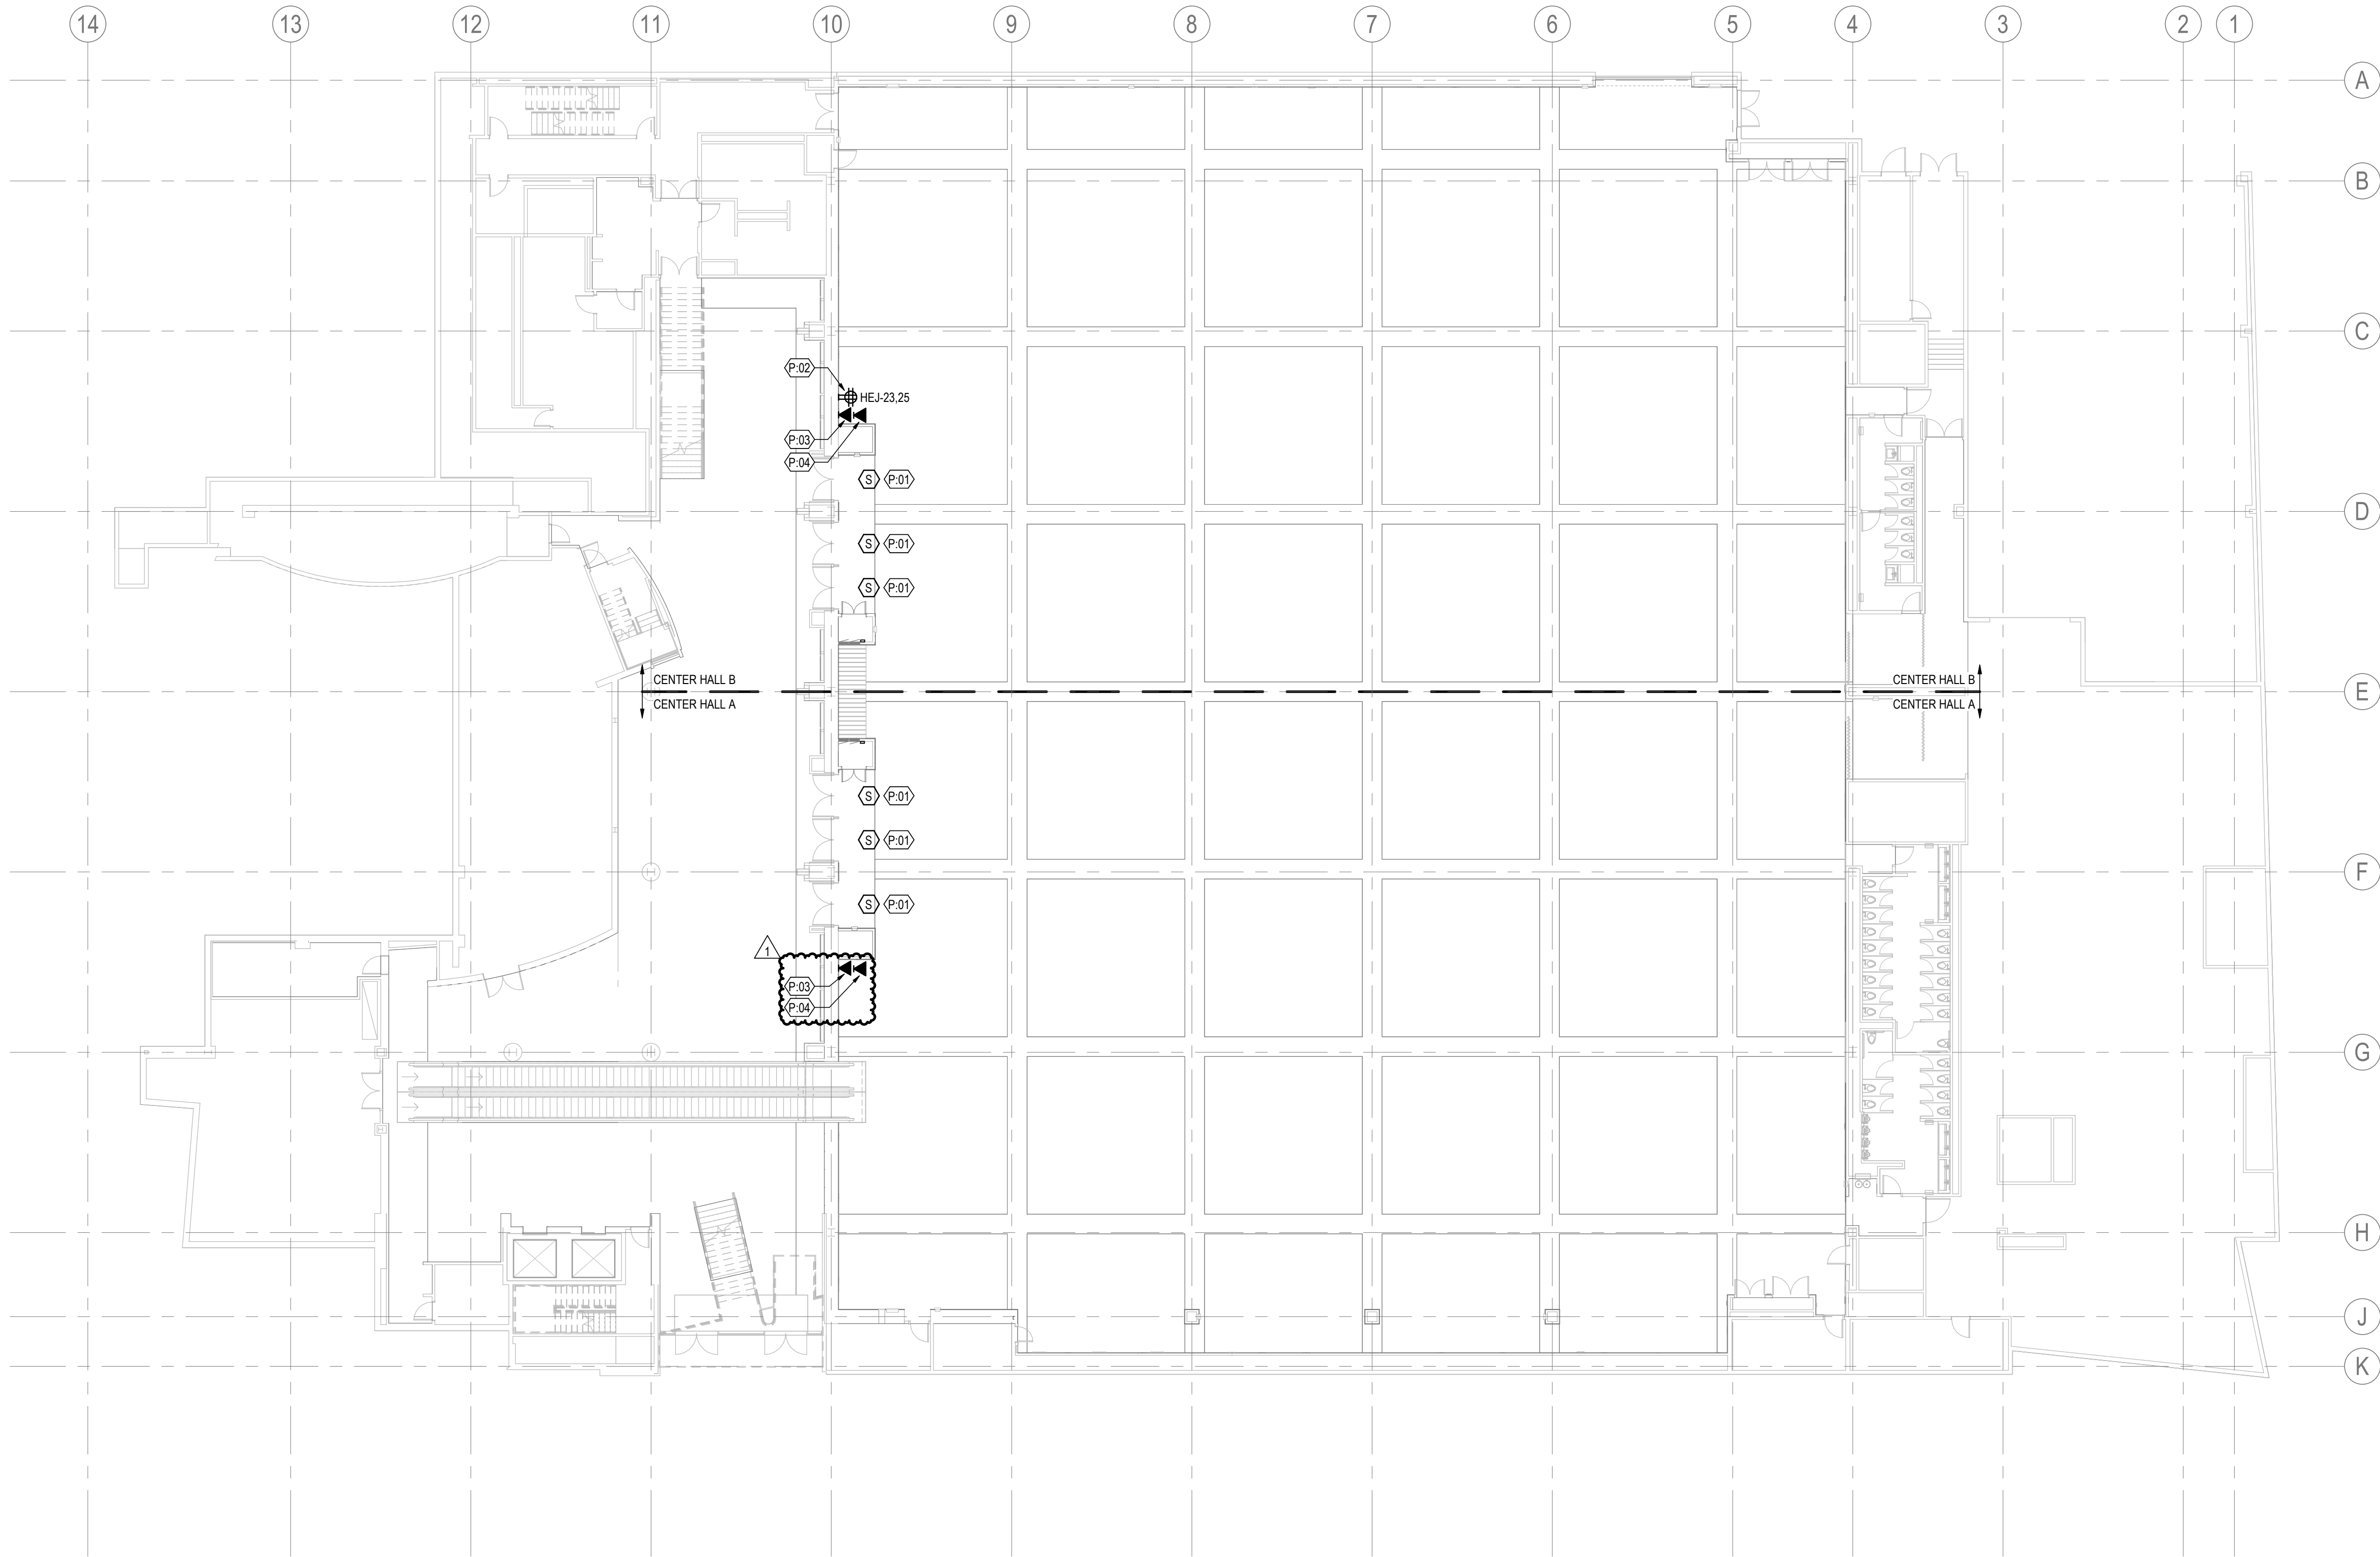

## KEY NOTES

- P-01 PROVIDE SMOKE DETECTOR WITH BLACK FINISH TO MATCH EXISTING SYSTEM. RECONNECT TO EXISTING INITIATING CIRCUIT.
- P-02 RELOCATED EXISTING RECEPTACLE. EXTEND EXISTING WIRE AND CONDUIT AS NECESSARY. REFER TO INTERIOR ELEVATION ON ARCHITECTURAL SHEET A402 FOR EXACT MOUNTING LOCATION.
- P-03 RELOCATED EXISTING DATA OUTLET. EXTEND EXISTING CONDUIT AND PROVIDE NEW FACE PLATE AND CAT CABLE TO NEW OUTLET LOCATION. REFER TO ARCHITECTURAL SHEET A402 FOR EXACT MOUNTING LOCATION. EXISTING CABLE TO BE REUSED IF SUFFICIENT SLACK IS AVAILABLE TO ACCOMMODATE NEW OUTLET LOCATION.
- P-04 RELOCATED EXISTING FIBER OUTLET. EXTEND EXISTING CONDUIT AND PROVIDE NEW FACE PLATE AND FIBER CABLE TO NEW OUTLET LOCATION. REFER TO ARCHITECTURAL SHEET A402 FOR EXACT MOUNTING LOCATION. EXISTING CABLE TO BE REUSED IF SUFFICIENT SLACK IS AVAILABLE TO ACCOMMODATE NEW OUTLET LOCATION.



## Meydenbauer Center: Center Hall Remodel

11100 NE 6th Street, Bellevue, Washington 98004

Submittal

## CONSTRUCTION DOCUMENTS

### Revisions


| No. | Date    | By | Description |
|-----|---------|----|-------------|
| 1   | 1/26/26 |    | Addendum #1 |

|             |          |
|-------------|----------|
| Drawn       | SY       |
| Checked     | TT       |
| LMN Proj No | 24101-01 |
| Date        | 1/5/2026 |
| Sheet Title |          |


## ELECTRICAL POWER PLAN - LEVEL 1

Sheet Number

**E101**

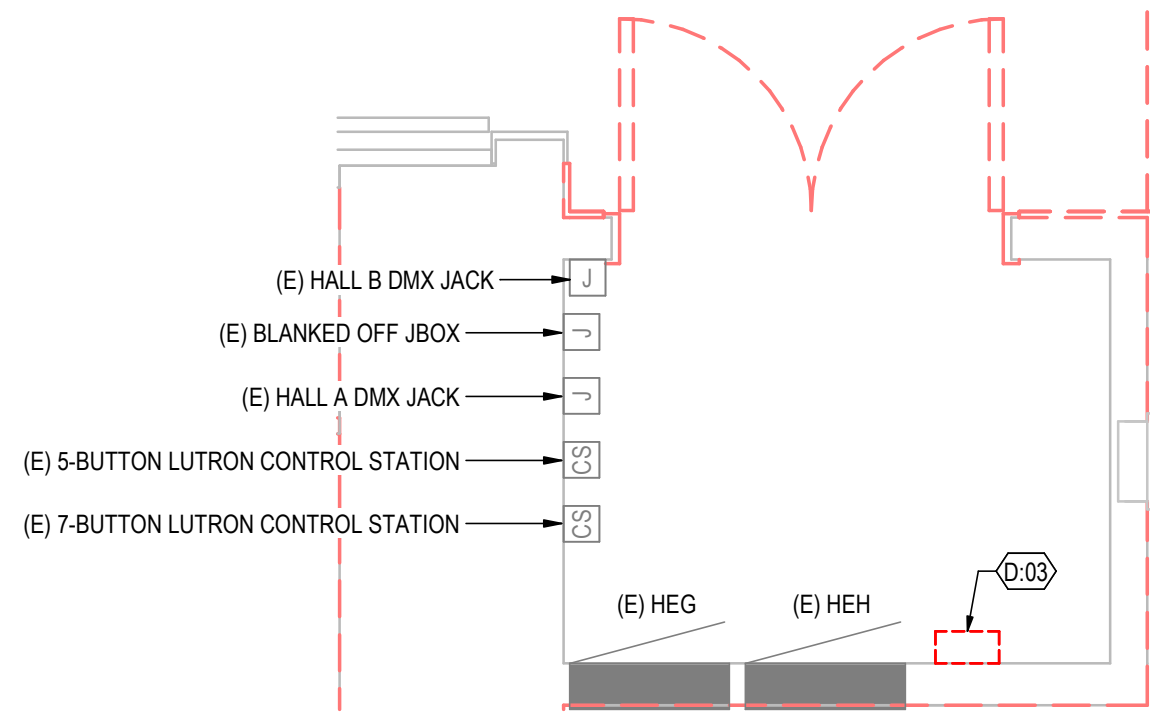

2 DEMO ENLARGED PLAN - ELEC 407A  
ED101 1/2" = 1'-0"

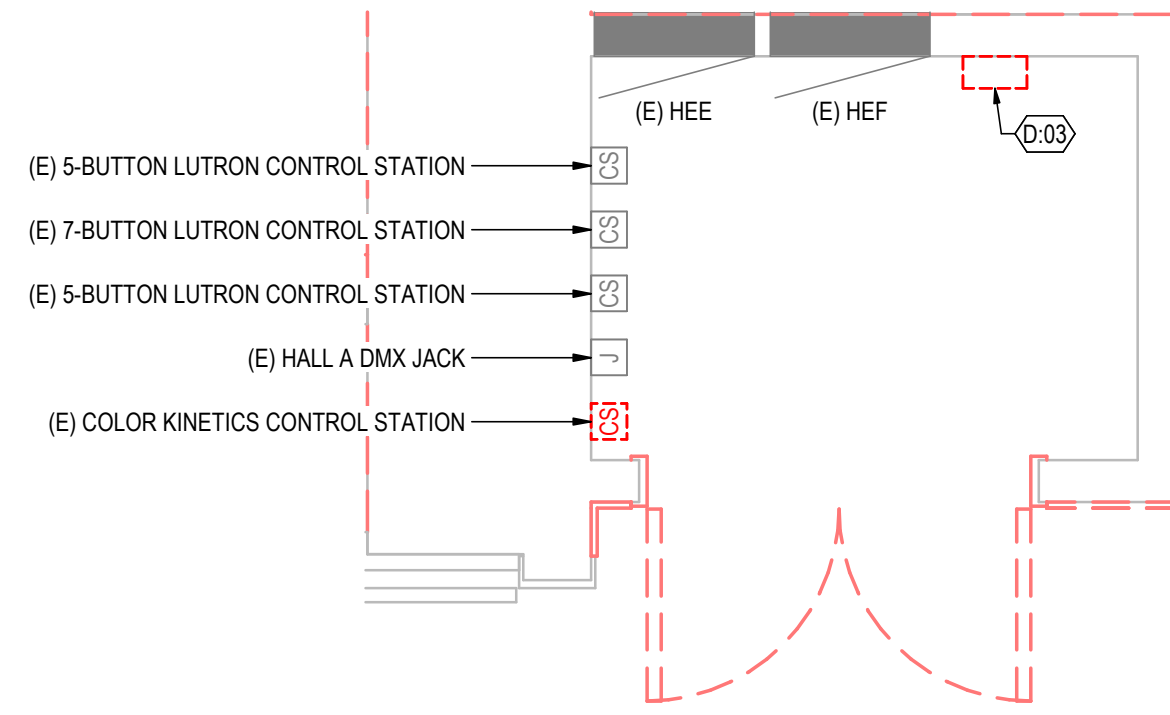

3 DEMO ENLARGED PLAN - ELEC 407B  
ED101 1/2" = 1'-0"

#### # KEY NOTES


- D.01 EXISTING LIGHTING CIRCUIT TO REMAIN IN AREA FOR REUSE, SEE NEW WORK PLAN.
- D.02 EXISTING DATA OUTLET TO BE RELOCATED. REMOVE EXISTING RJ45 FACEPLATE AND BACK PULL CAT CABLE TO A LOCATION WHERE IT WILL NOT BE DAMAGED DURING CONSTRUCTION. REMOVE EXISTING CONDUIT TO A POINT THAT IT WILL NOT INTERFERE WITH NEW CONSTRUCTION AND CAN BE EXTENDED TO SUPPORT THE NEW DATA OUTLET LOCATION APPROXIMATELY 5 FEET AWAY.
- D.03 DEMOLISH COLOR KINETICS PLAYERS ASSOCIATED WITH COLOR CHANGING LIGHTING UPLIGHTS IN CENTER HALL TO BE DEMOLISHED.
- D.04 EXISTING LIGHTING CIRCUIT TO REMAIN IN AREA FOR REUSE. DEMOLISH DMX CABLING BACK TO PLAYER 3 LOCATED IN ELEC 407A/407B.
- D.05 DEMOLISH EXISTING SMOKE DETECTOR. EXISTING INITIATING CIRCUIT TO REMAIN FOR REUSE.
- D.06 DISCONNECT AND PROTECT EXISTING EXIT SIGN DURING DEMOLITION AND INSTALLATION OF NEW WALL FINISH AT THIS LOCATION.
- D.07 EXISTING RECEPTACLE TO BE RELOCATED ALONG WALL, SEE SHEET E101 FOR LOCATION.

#### # KEY NOTES

- D.08 EXISTING FIBER OUTLET TO BE RELOCATED. REMOVE EXISTING FIBER FACEPLATE AND BACK PULL FIBER CABLE TO A LOCATION WHERE IT WILL NOT BE DAMAGED DURING CONSTRUCTION. REMOVE EXISTING CONDUIT TO A POINT THAT IT WILL NOT INTERFERE WITH NEW CONSTRUCTION AND CAN BE EXTENDED TO SUPPORT THE NEW FIBER OUTLET LOCATION APPROXIMATELY 5 FEET AWAY.

#### GENERAL NOTES

1. REFER TO SHEET 1/E201 FOR LOCATION OF PANELS EBWA, BWA, LCPA, AND LCPB.

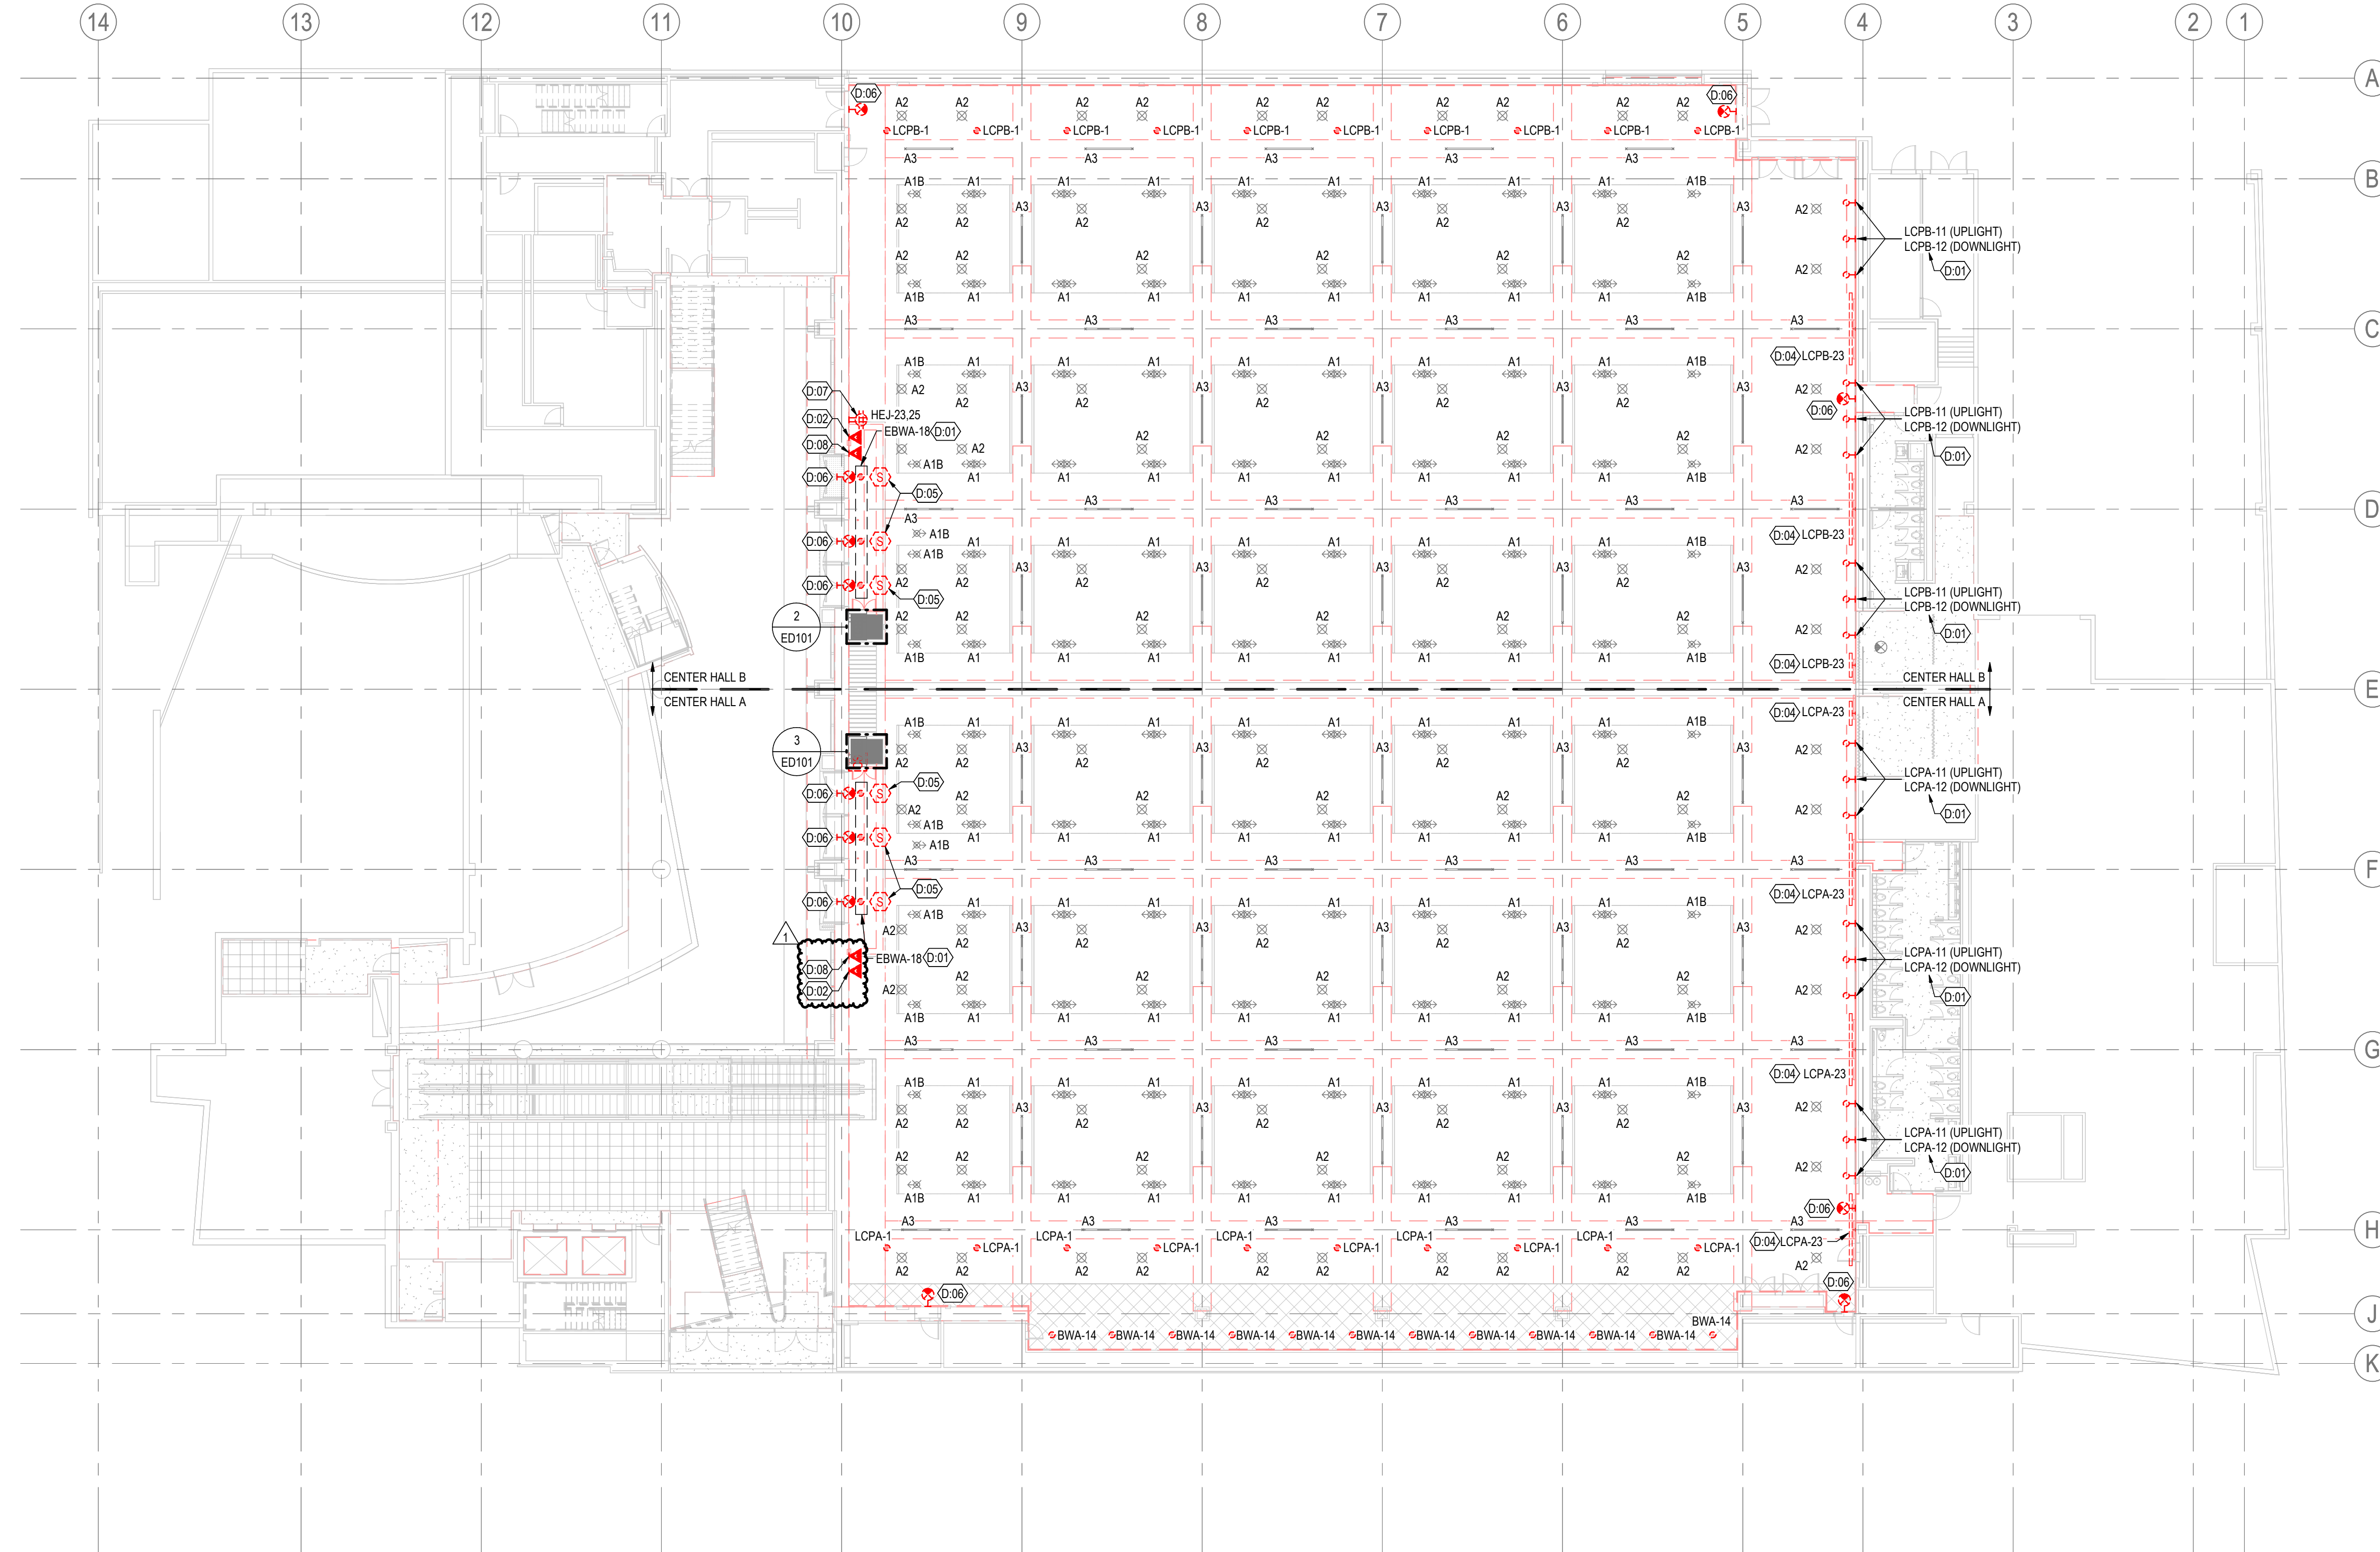

1 DEMO ELECTRICAL PLAN - LEVEL 1  
ED101 1/16" = 1'-0"



## Meydenbauer Center: Center Hall Remodel

11100 NE 6th Street, Bellevue, Washington 98004

Submittal

## CONSTRUCTION DOCUMENTS

#### Revisions


| No. | Date    | By | Description |
|-----|---------|----|-------------|
| 1   | 1/26/26 |    | Addendum #1 |

Drawn SY  
Checked TT  
LMN Proj No 24101-01  
Date 1/5/2026

Sheet Title

## DEMO ELECTRICAL PLAN - LEVEL 1

Sheet Number

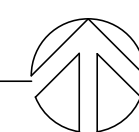

# ED101